


PERSPECTIVE


NOT DRAWN TO SCALE

OWNER PHILIPPINE FIBER INDUSTRY DEVELOPMENT AUTHORITY <small>111 PAMPALAN RD., COMPOUND ELECTRICAL ROAD 1000 BAHAY KURAT CITY</small>	PROJECT TITLE REPAIR AND IMPROVEMENT OF SHED FOR FPUL 15kVA GENSET <small>516 COMPOUND JERAPAYAT, TANDA, ORIZON CITY</small>	SHEET CONTENTS AS SHOWN	PREPARED BY <small>JUAN CARLOS L. NUENA PROJECT ENGINEER</small> DATE: 27/08/2024 BY: DATE: 27/08/2024	REVIEWED BY <small>DE-LOM SORIANO PROJECT MANAGER</small> DATE: 27/08/2024 BY: DATE: 27/08/2024	PROJECT MANAGER <small>ENGR. RAMIL B. BARCELONA, MPA PROJECT MANAGER</small>	APPROVED BY <small>ARNOLD L. ATIENZA PROJECT DIRECTOR</small>	SHEET NO. <div style="border: 1px solid black; border-radius: 50%; width: 30px; height: 30px; display: flex; align-items: center; justify-content: center;"> <div style="text-align: center;">1 6</div> </div>
------------------------------------------------------------------------------------------------------------------------------------------------------------	-----------------------------------------------------------------------------------------------------------------------------------------------	-----------------------------------	------------------------------------------------------------------------------------------------------------------------	-----------------------------------------------------------------------------------------------------------------	-------------------------------------------------------------------------------------	----------------------------------------------------------------------	-----------------------------------------------------------------------------------------------------------------------------------------------------------------------------------------------------------------------

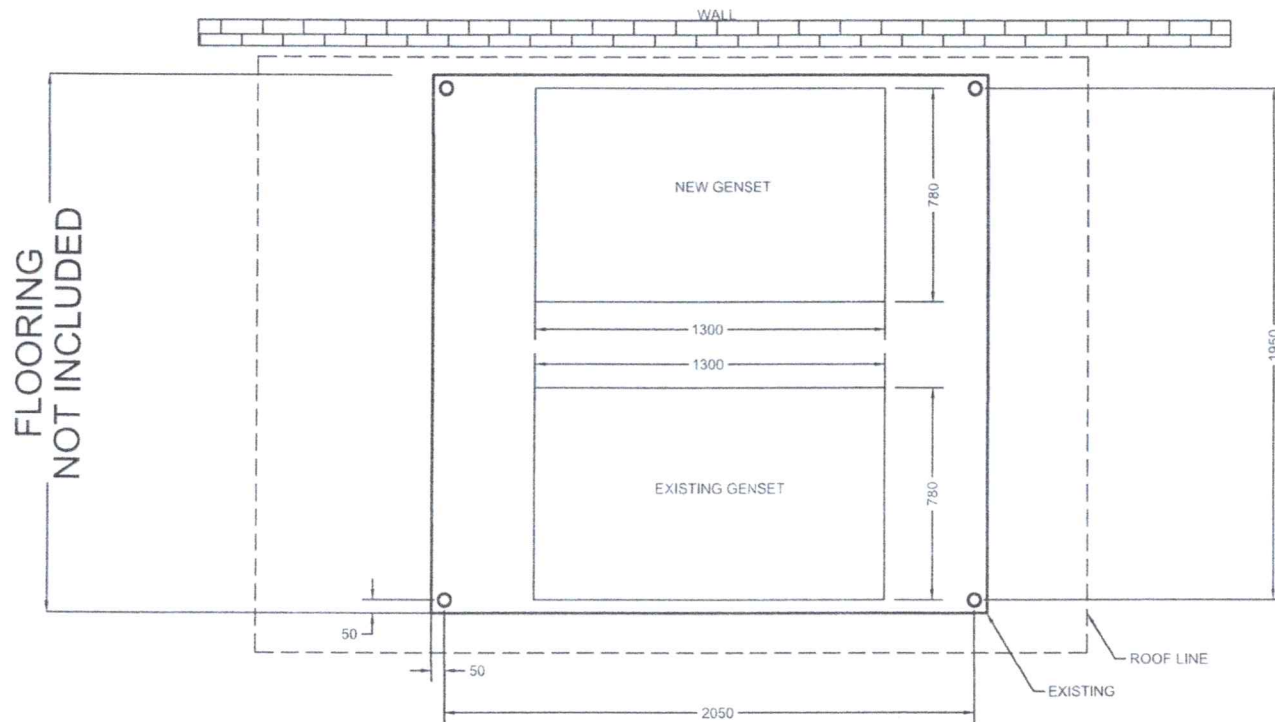



FLOOR PLAN
 SCALE 1:20 MM


<small>OWNER</small> PHILIPPINE FIBER INDUSTRY DEVELOPMENT AUTHORITY <small>37 PCAP BUILDING SA COMPOUND, ELLIPTICAL ROAD, DELMAN, QUEZON CITY</small>	<small>PROJECT TITLE</small> REPAIR AND IMPROVEMENT OF SHED FOR FPUL 15KVA GENSET <small>(SAI COMPOUND, WISAYAS AVE, YASNA, QUEZON CITY)</small>	<small>SHEET CONTENTS</small> AS SHOWN	<small>PREPARED BY</small> JUSTIN JOSEPH J. NUEVA <small>(ARCHITECT/DESIGNER)</small> <small>ERC 0118487</small> <small>PTC</small> <small>TIN</small> <small>DATE EXPIRES: FEBRUARY 05, 2028</small>	<small>REVIEWED BY</small> PERDIO M. SORIANO III <small>(REGISTERED ELECTRICAL ENGINEER)</small> <small>ERC 050604</small> <small>PTC</small> <small>TIN</small> <small>DATE EXPIRES: SEPTEMBER 24, 2025</small>	<small>RECOMMENDATION APPROVAL</small> ENGR. RAMIL B. BARCELONA, MPA <small>ERC DEPUTY EXECUTIVE DIRECTOR</small>	<small>APPROVED BY</small> ARNOLD M. ATIENZA <small>EXECUTIVE DIRECTOR</small>	<small>SHEET NO.</small> <div style="border: 1px solid black; border-radius: 50%; width: 30px; height: 30px; display: flex; align-items: center; justify-content: center; margin: 0 auto;"> <div style="display: flex; flex-direction: column; align-items: center; justify-content: center;"> 2 6 </div> </div>
------------------------------------------------------------------------------------------------------------------------------------------------------------------------------	-----------------------------------------------------------------------------------------------------------------------------------------------------------	-------------------------------------------	-------------------------------------------------------------------------------------------------------------------------------------------------------------------------------------------------------------------------	------------------------------------------------------------------------------------------------------------------------------------------------------------------------------------------------------------------------------------	-------------------------------------------------------------------------------------------------------------------------	--------------------------------------------------------------------------------------	-----------------------------------------------------------------------------------------------------------------------------------------------------------------------------------------------------------------------------------------------------------------------------------------------------------------------------------------------

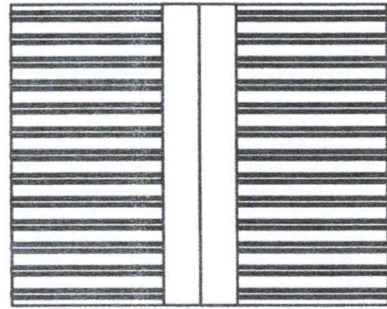


TOP VIEW
SCALE 1:40 MM

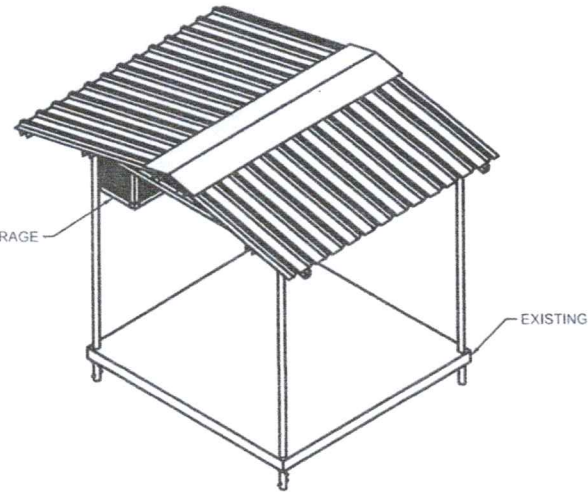

ISOMETRIC VIEW
SCALE 1:40 MM

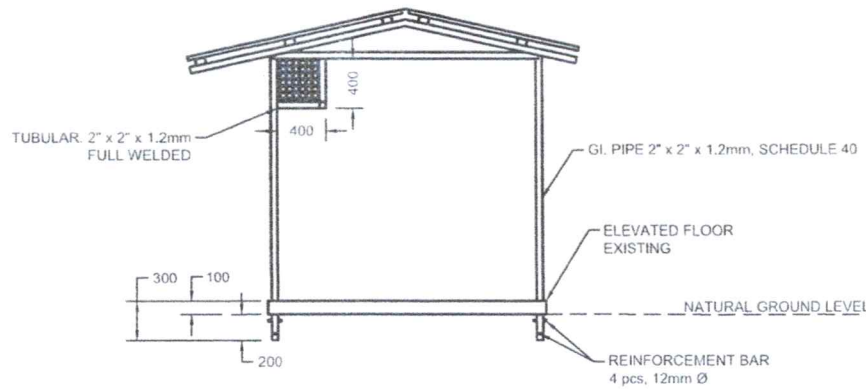



FRONT VIEW
SCALE 1:40 MM

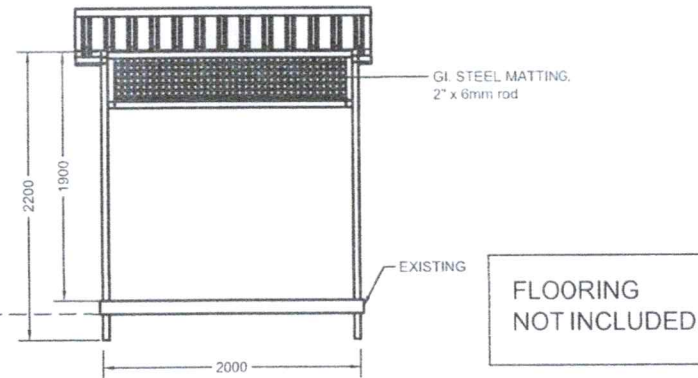


RIGHT SIDE VIEW
SCALE 1:40 MM

FLOORING
NOT INCLUDED

OWNER PHILIPPINE FIBER INDUSTRY DEVELOPMENT AUTHORITY 37 PCAP BUILDING DA, COMPOUND, ELLIPTICAL ROAD, DILMAN, QUEZON CITY	PROJECT TITLE REPAIR AND IMPROVEMENT OF SHED FOR FPUL 15KVA GENSET BAI COMPOUND, IRISAYAS AVE, VASRA, QUEZON CITY	SHEET CONTENTS AS SHOWN	PREPARED BY JUSTIN JOSEPH J. NUEVA MECHANICAL ENGINEER	REVIEWED BY PEPITO M. SORIANO JR. MECHANICAL ENGINEER	RECOMMENDING APPROVAL ENGR. RAMIL B. BARCELONA, MPA PRC DEPUTY EXECUTIVE DIRECTOR	APPROVED BY ARNOLD "AL" ATIENZA EXECUTIVE DIRECTOR	SHEET NO. 3 6
			PRC 0110482	PRC 010504			
			DATE EXPIRED: FEBRUARY 01, 2019	DATE EXPIRED: SEPTEMBER 29, 2020			

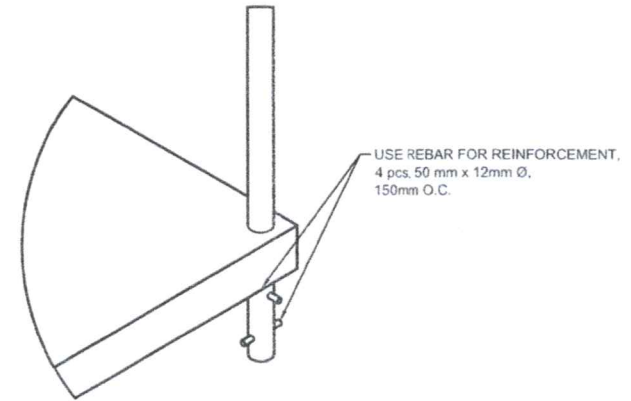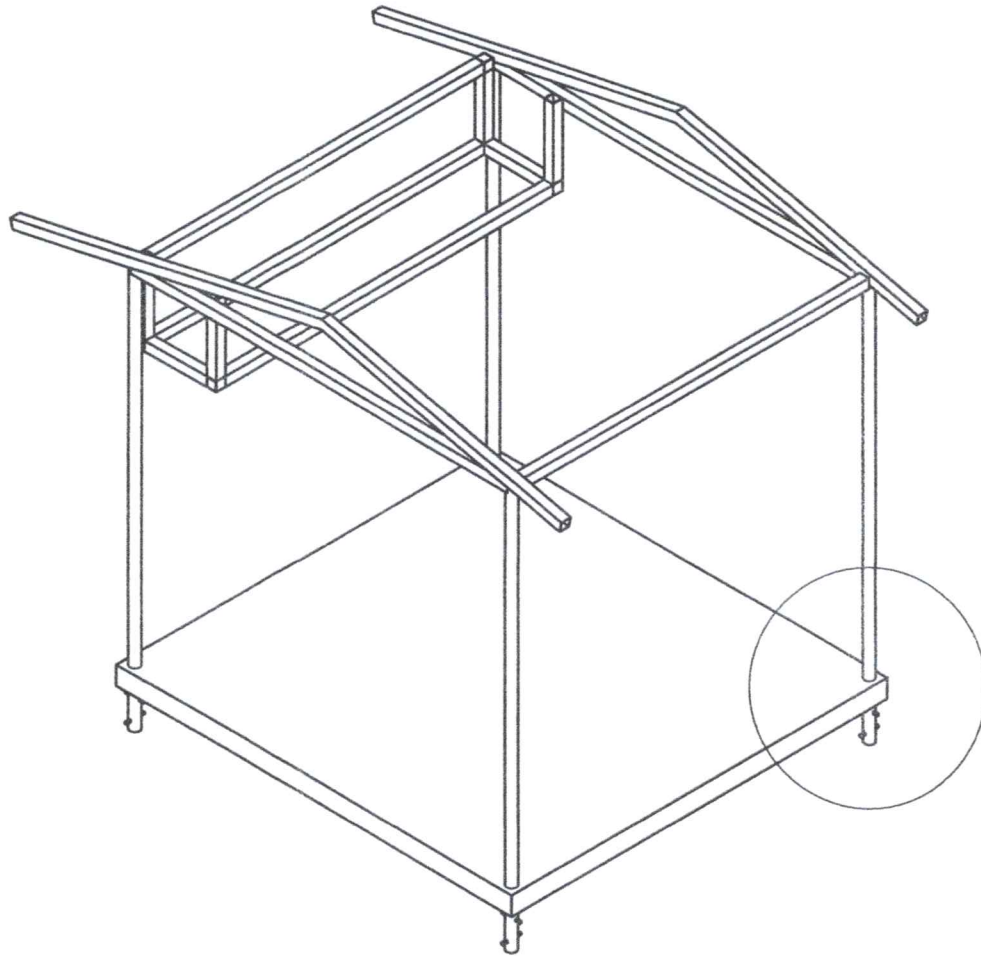
 




FOOTING DETAILS 1

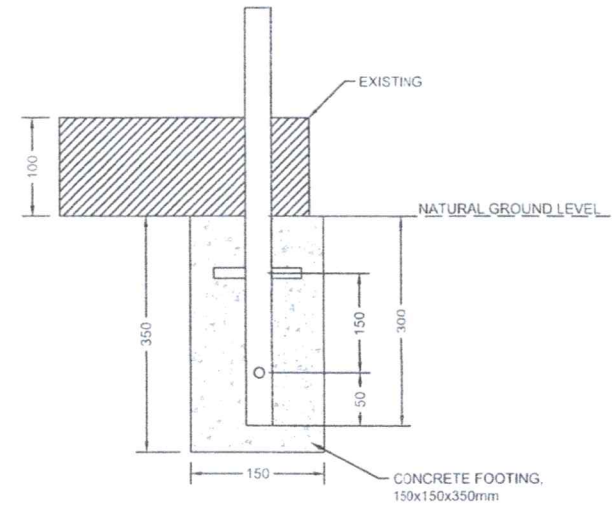




FOOTING DETAILS 2

 **COLUMN DETAILS**
SCALE 1:20 MM

OWNER PHILIPPINE FIBER INDUSTRY DEVELOPMENT AUTHORITY <small>89 PCAP BIRLONG DA COMPOUND, ELLIPTICAL ROAD, DELMAN, QUEZON CITY</small>	PROJECT TITLE REPAIR AND IMPROVEMENT OF SHED FOR FPUL 15kVA GENSET <small>38M COMPOUND, VISAYAS AVE. 15381, QUEZON CITY</small>	SHEET CONTENTS AS SHOWN	PREPARED BY <small>JUSTIN JOSEPH J. NUEVA</small> <small>PROFESSIONAL ENGINEER</small> <small>PRC: 0114443</small> <small>PTR</small> <small>DTN</small> <small>DATE EXPIRED: FEBRUARY 06, 2028</small>	REVIEWED BY <small>PEPITO M. SOLIANO III</small> <small>PROFESSIONAL ELECTRICAL ENGINEER</small> <small>PRC: 038054</small> <small>PTR</small> <small>DTN</small> <small>DATE EXPIRED: SEPTEMBER 26, 2025</small>	RECOMMENDING APPROVAL  ENGR. FAMIL B. BARCELONA, MPA <small>CHIEF DEPUTY EXECUTIVE DIRECTOR</small>	APPROVED BY  ARNOLD A. M. ATIENZA <small>EXECUTIVE DIRECTOR</small>	SHEET NO. <div style="border: 1px solid black; border-radius: 50%; width: 30px; height: 30px; display: flex; align-items: center; justify-content: center;"> 4 6 </div>
-----------------------------------------------------------------------------------------------------------------------------------------------------	----------------------------------------------------------------------------------------------------------------------------------------------	-----------------------------------	---------------------------------------------------------------------------------------------------------------------------------------------------------------------------------------------------------------------------	-------------------------------------------------------------------------------------------------------------------------------------------------------------------------------------------------------------------------------------	----------------------------------------------------------------------------------------------------------------------------------------------------------------------------------------------------------	--------------------------------------------------------------------------------------------------------------------------------------------------------------------------	---------------------------------------------------------------------------------------------------------------------------------------------------------------------------------------------------------------------------------------------------------------

 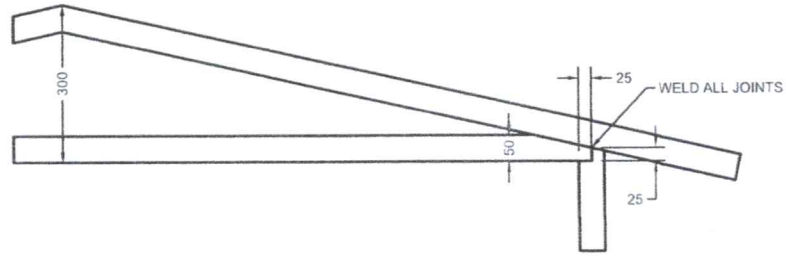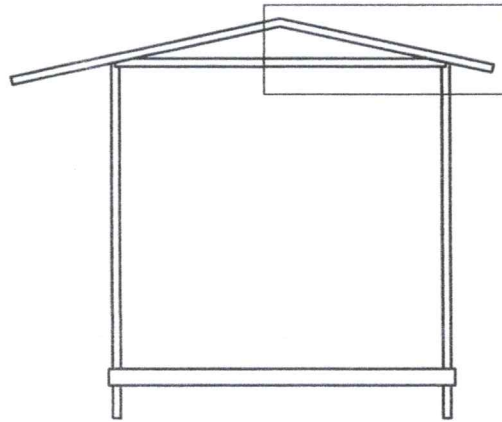


TRUSS JOINT DETAILS

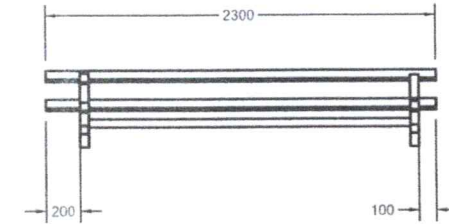
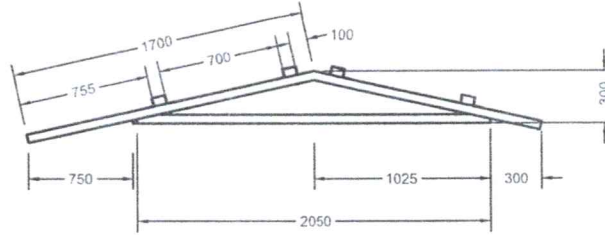
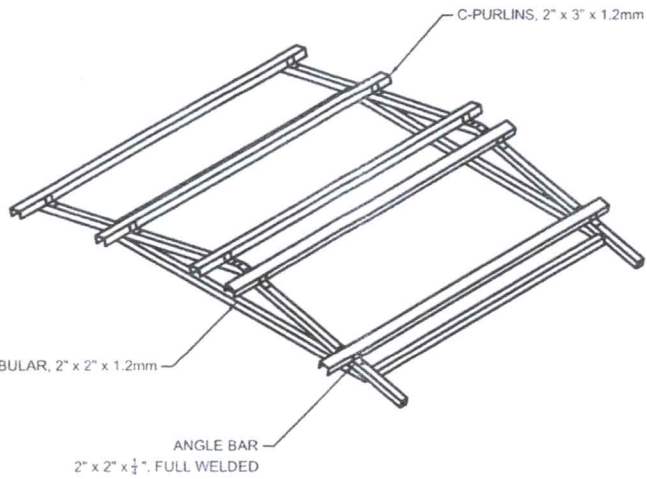


 
TRUSS DETAILS




 
SCALE 1:20 MM

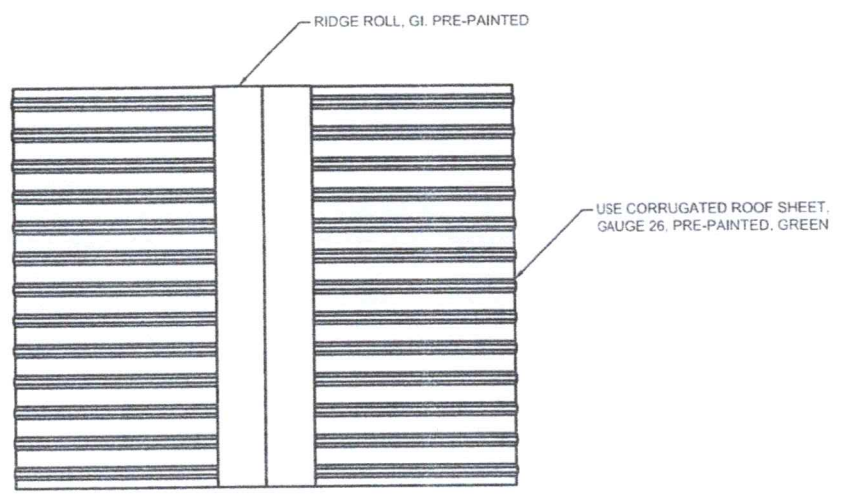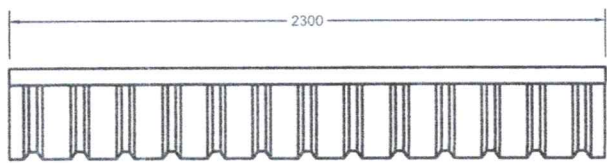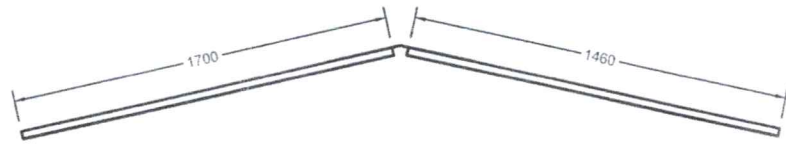

OWNER PHILIPPINE FIBER INDUSTRY DEVELOPMENT AUTHORITY <small>3F PCAP BUILDING, DA COMPOUND, ELLIPTICAL ROAD, DILIMAN, QUEZON CITY</small>	PROJECT TITLE REPAIR AND IMPROVEMENT OF SHED FOR FPUL 15KVA GENSET <small>888 COMPOUND, JISAYAS AVE, PASPA, QUEZON CITY</small>	SHEET CONTENTS AS SHOWN	PREPARED BY <small>JOSEPH J. NUEVA</small> <small>REGISTERED ELECTRICAL ENGINEER</small>	REVIEWED BY <small>PEPITO M. SORDAN III</small> <small>REGISTERED ELECTRICAL ENGINEER</small>	RECOMMENDING APPROVAL <small>ENGR. RAMIL B. BARCELONA, MPA</small> <small>REG. DEPUTY SECRETARY DIRECTOR</small>	APPROVED BY <small>ARNOLD T. ATIENZA</small> <small>EXECUTIVE DIRECTOR</small>	SHEET NO. 5 6
--------------------------------------------------------------------------------------------------------------------------------------------------------	----------------------------------------------------------------------------------------------------------------------------------------------	----------------------------	------------------------------------------------------------------------------------------------	-----------------------------------------------------------------------------------------------------	------------------------------------------------------------------------------------------------------------------------	--------------------------------------------------------------------------------------	---------------------




ROOF DETAILS
 SCALE 1:30 MM

OWNER PHILIPPINE FIBER INDUSTRY DEVELOPMENT AUTHORITY <small>3F HCLP BUILDING DR. COMPOUND, ELLIPTICAL ROAD, TAGAYAN, QUEZON CITY</small>	PROJECT TITLE REPAIR AND IMPROVEMENT OF SHED FOR FPUL 15kVA GENSET <small>881 COMPOUND, VISAYAS AVE. VASNA, QUEZON CITY</small>	SHEET CONTENTS <p style="text-align: center;">AS SHOWN</p>	PREPARED BY  JUSTINE JOSEPH J. NUEVA <small>ARCHITECT-REGISTERED</small>	REVIEWED BY  PEPITO M. SORIANO III <small>ARCHITECT-REGISTERED</small>	RECOMMENDING APPROVAL  ENGR. FAMIL B. BARCELONA, MPA <small>DEPUTY EXECUTIVE DIRECTOR</small>	APPROVED BY  ARNOLD M. L. ATIENZA <small>EXECUTIVE DIRECTOR</small>	SHEET NO. <div style="border: 1px solid black; border-radius: 50%; width: 30px; height: 30px; margin: 0 auto; display: flex; align-items: center; justify-content: center;"> <div style="border-bottom: 1px solid black; width: 100%; text-align: center;">6</div> <div style="width: 100%; text-align: center;">6</div> </div>
			<small>PROJ: 1114441</small> <small>DATE: EXPIRES FEBRUARY 01, 2024</small>	<small>PREC: 20244</small> <small>DATE: EXPIRES SEPTEMBER 29, 2025</small>			